


**GENERAL NOTES:**  
ALL WORK AT THIS FACILITY IS TO BE PERFORMED DURING UNOCCUPIED HOURS. COORDINATE ALL SYSTEM SHUTDOWNS WITH OWNER. EXISTING HEATING AND CHILLED WATER SYSTEM ARE TO REMAIN IN OPERATION DURING CONSTRUCTION WHILE BUILDING IS OCCUPIED.

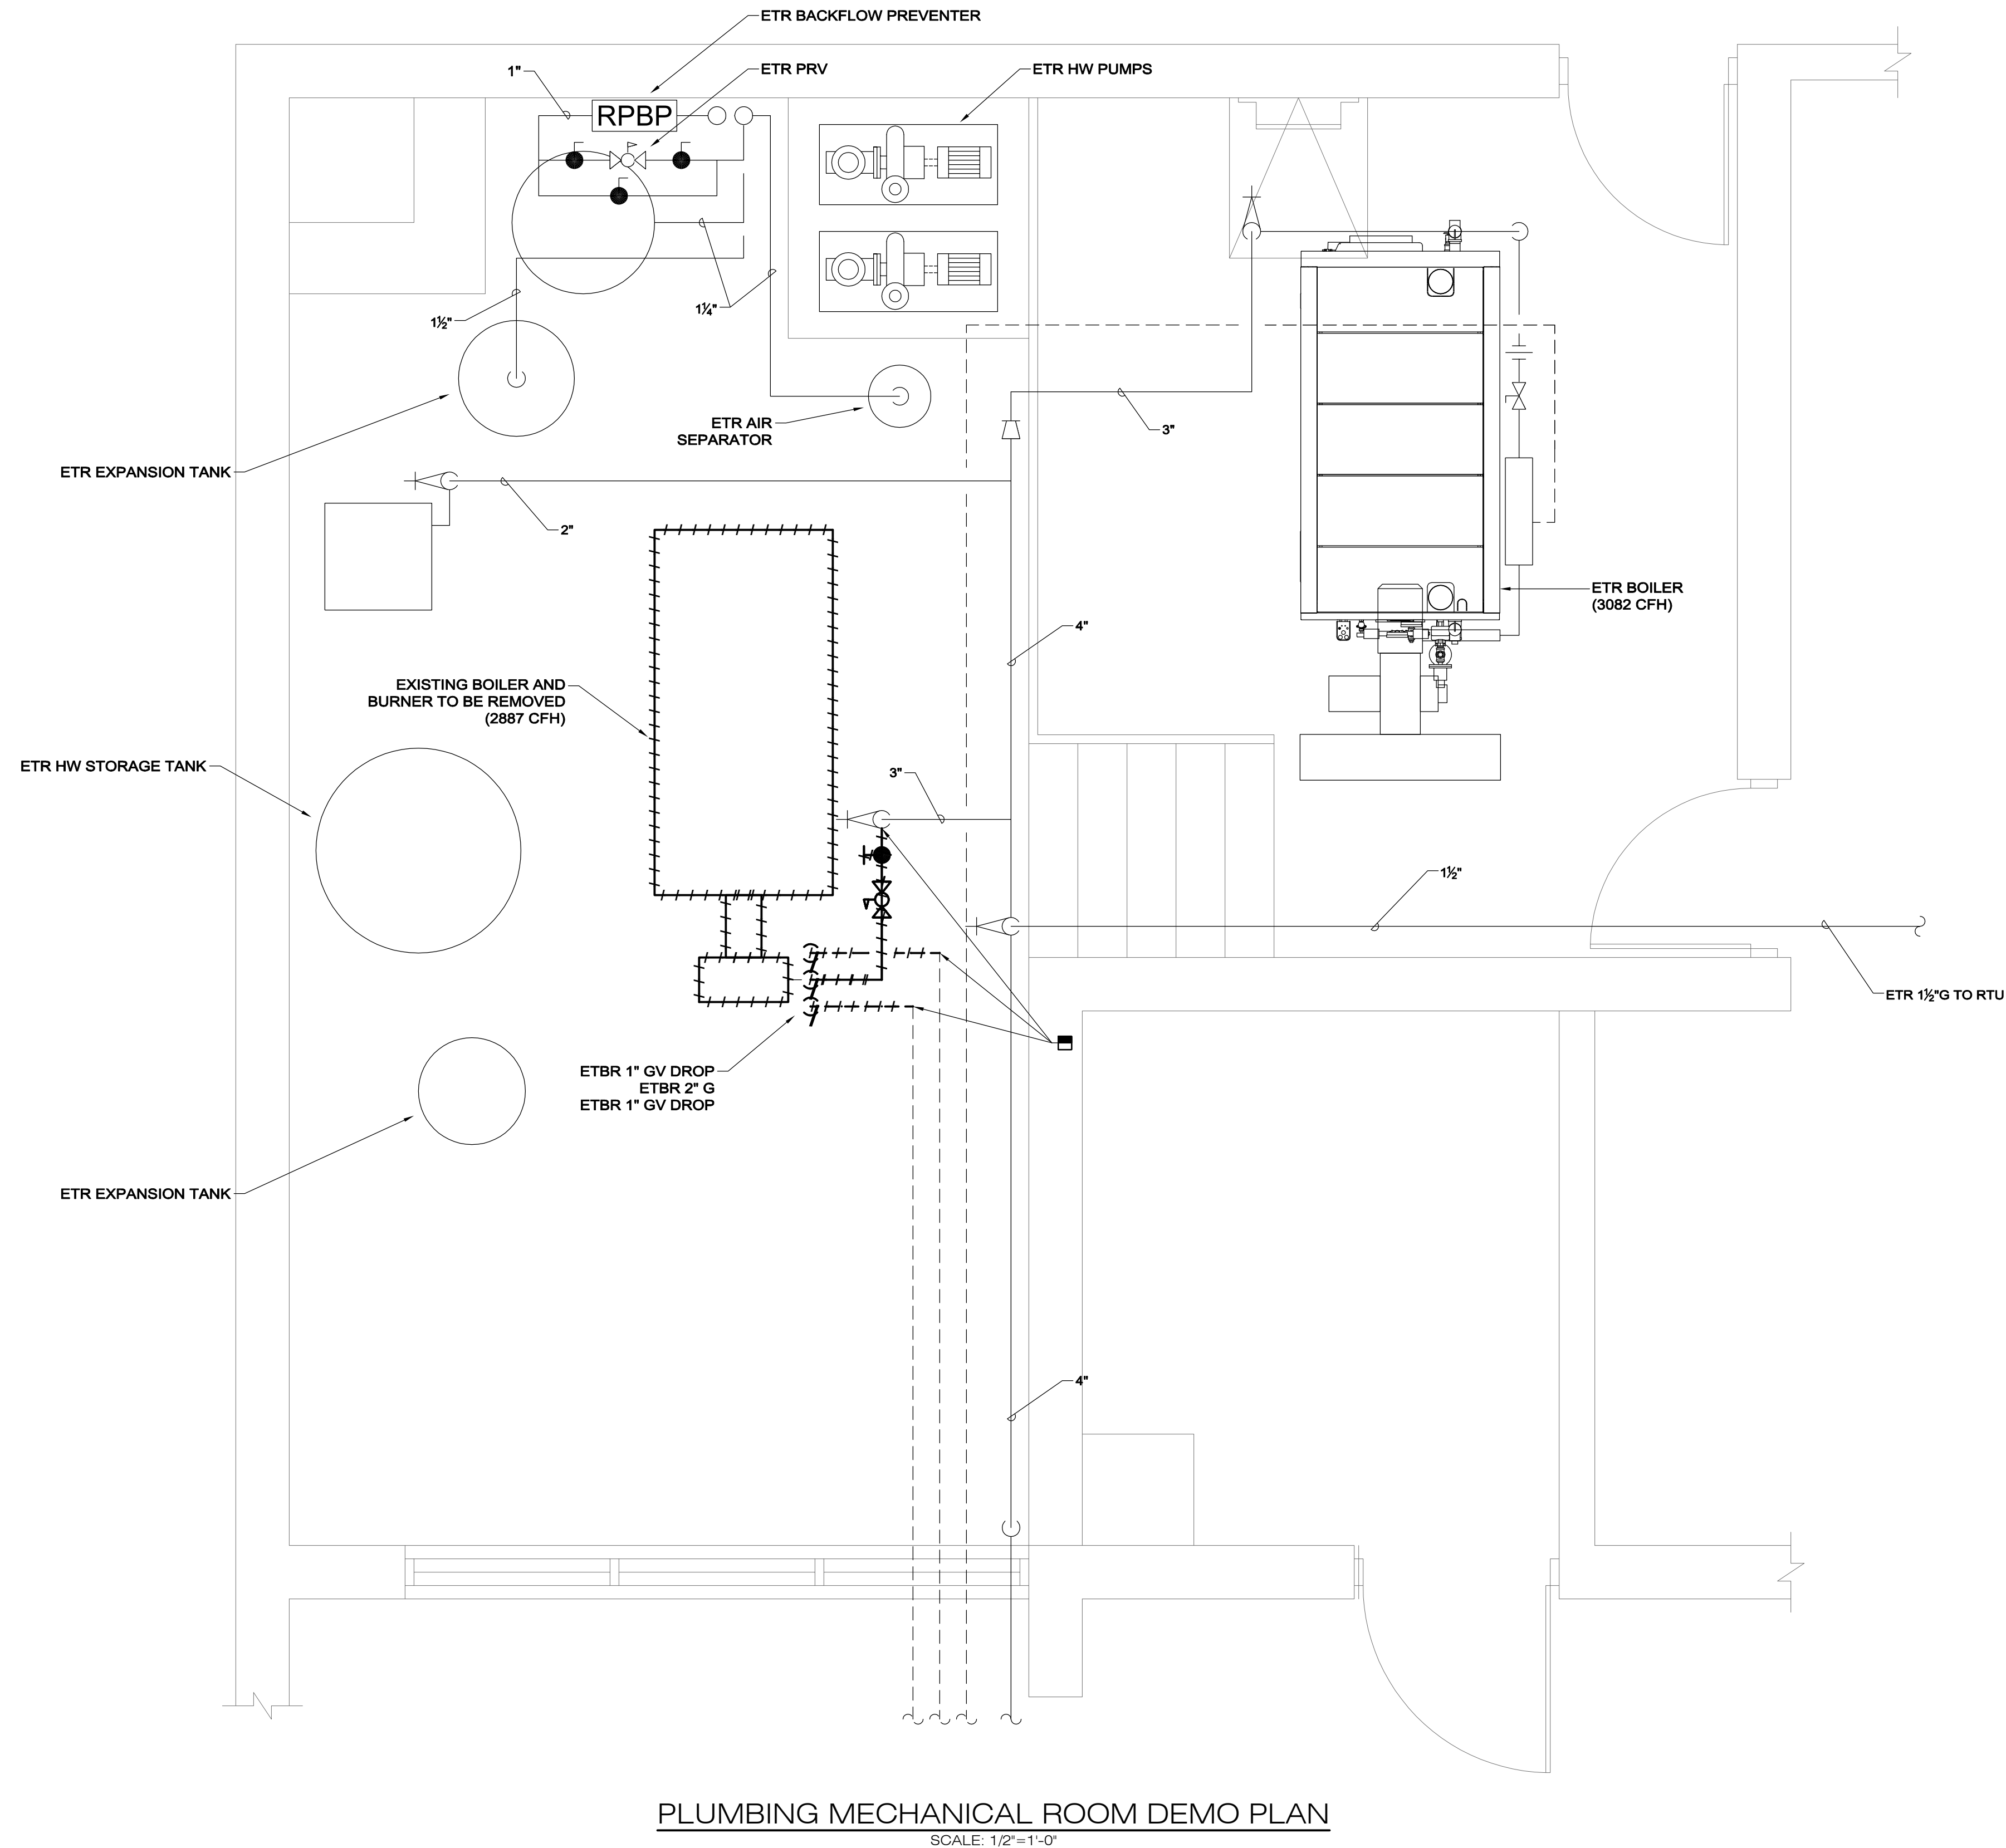

**PLUMBING MECHANICAL ROOM DEMO PLAN**

SCALE: 1/2"=1'-0"

**REVISIONS**

DATE	CHK	DESCRIPTION

**SEAL**

**PROJECT**

NUMBER: 0190327  
DATE: 07/18/2019  
**BLUEBERRY HILL SCHOOL BOILER REPLACEMENT**

**DRAWING**

DRAWN BY: RSL  
CHECKED BY: RSL  
SCALE: 1/2" = 1'-0"

**CONSTRUCTION DOCUMENTS**  
07-18-2019

**PLUMBING MECHANICAL ROOM DEMO FLOOR PLAN**

